

JOB NO.	8-2-10
DRAWN BY	CMH
CHECKED BY	CMH
DATE	4-22-2010
REVISIONS	
6-30-10	

SHEET NO.

1.3



MOUNTAIN ISLAND LAKE APARTMENTS  
 MT. HOLLY/HUNTERSVILLE RD AND HWY 16  
 CHARLOTTE, NC 28216


OWNER / DEVELOPER:  
 MOUNTAIN ISLAND APARTMENTS, LLC  
 1329 EAST MOREHEAD STREET, SUITE 200  
 CHARLOTTE, NC 28204

CHARLES M. HILL, A.I.A.  
 ARCHITECT  
 NEBO, NC  
 TELEPHONE (828) 659-1540

2 AND 3 BEDROOM UNIT BLDG. PLAN / 24 UNIT BLDG. TYPE 'C'

2 AND 3 BEDROOM UNIT / FOUNDATION PLAN


SCALE: 1/8" = 1'0"

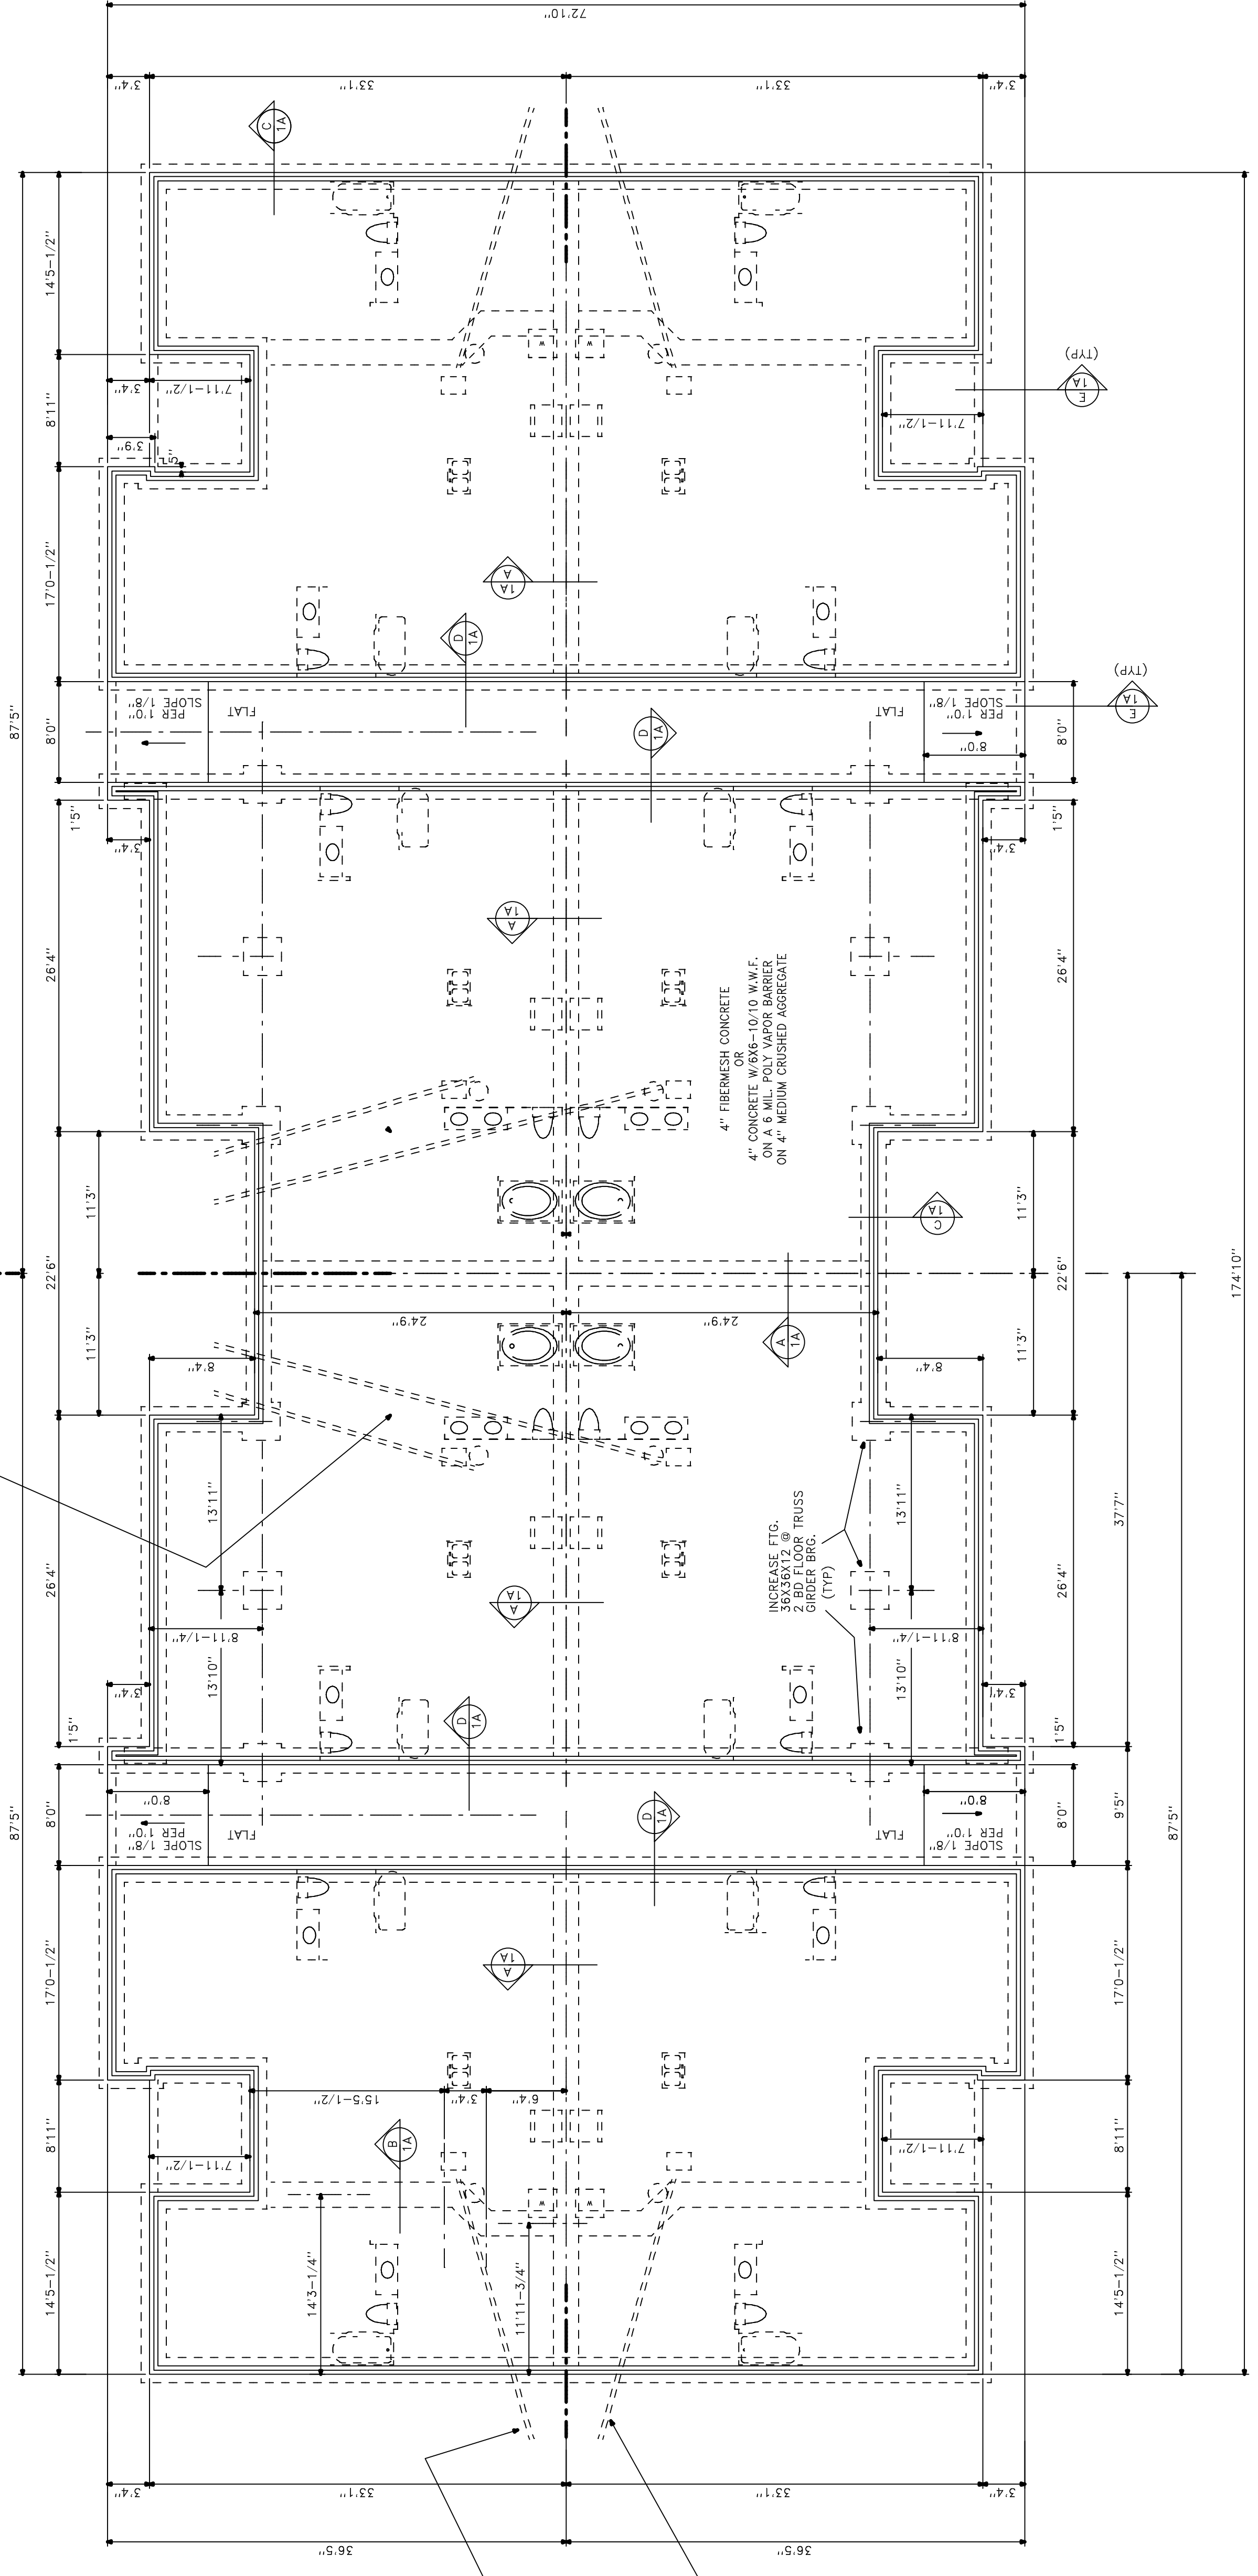

NOTE:  
 PROVIDE 3/4" PVC CONDENSATION DRAIN ALL AHU (TYP ALL UNITS)  
 PROVIDE ADEQUATE SIZE PVC PIPE UNDER SLAB (INTERIOR UNITS) COLLECT CONDENSATE AND FREON LINES AS REQUIRED (TYP)

NOTE:  
 PROVIDE 3/4" PVC CONDENSATION DRAIN ALL AHU (TYP ALL UNITS)  
 PROVIDE ADEQUATE SIZE PVC PIPE UNDER SLAB (INTERIOR UNITS) COLLECT CONDENSATE AND FREON LINES AS REQUIRED (TYP)

 NOTE:  
 PROVIDE 3/4" COPPER OR CPVC DRAIN FOR W.H. (TYP. ALL UNITS) EQUIP. W/H. W/ DRAIN PAN UNDER SLAB (TYP. ALL UNITS) PER LOCAL BLDG. CODE  
 PROVIDE 3/4" PVC CONDENSATION DRAIN ALL AHU (TYP ALL UNITS)



BLDG. CENTERLINE ABOUT CENTERLINE

BLDG. SYMMETRICAL ABOUT CENTER