

JOB NO.	
DRAWN BY	CMH
CHECKED BY	CMH
DATE	5-11-2010
REVISIONS	
8-2-10	

2 AND 3 BEDROOM UNIT BLDG. PLAN / 24 UNIT BLDG. TYPE 'C'.

STEPPED FOUNDATION
AT CENTER PARTY WALL
FOR ORIENTATION OF STEP
SEE SITE PLAN

2 AND 3 BEDROOM UNIT / FOUNDATION PLAN


SCALE: 1/8" = 1'0"

NOTE: PROVIDE 3/4" COPPER OR CPVC
DRAIN FOR W.H. (TYP. ALL UNITS)
EQUIP. TO BE INSTALLED IN
EQUIP. ROOM TO DRAIN PAN
PER LOCAL BLDG. CODE

PROVIDE 3/4" PVC CONDENSATION
DRAIN ALL AHU (TYP ALL UNITS)

NOTE:
PROVIDE 3/4" PVC CONDENSATION
DRAIN ALL AHU (TYP ALL UNITS)
PROVIDE ADEQUATE SIZE PVC PIPE
UNDER SLAB (INTERIOR UNITS)
CONDENSATE AND FREON
LINES AS REQUIRED
(TYP)

NOTE:
PROVIDE 3/4" PVC CONDENSATION
DRAIN ALL AHU (TYP ALL UNITS)
PROVIDE ADEQUATE SIZE PVC PIPE
UNDER SLAB (INTERIOR UNITS)
CONDENSATE AND FREON
LINES AS REQUIRED
(TYP)

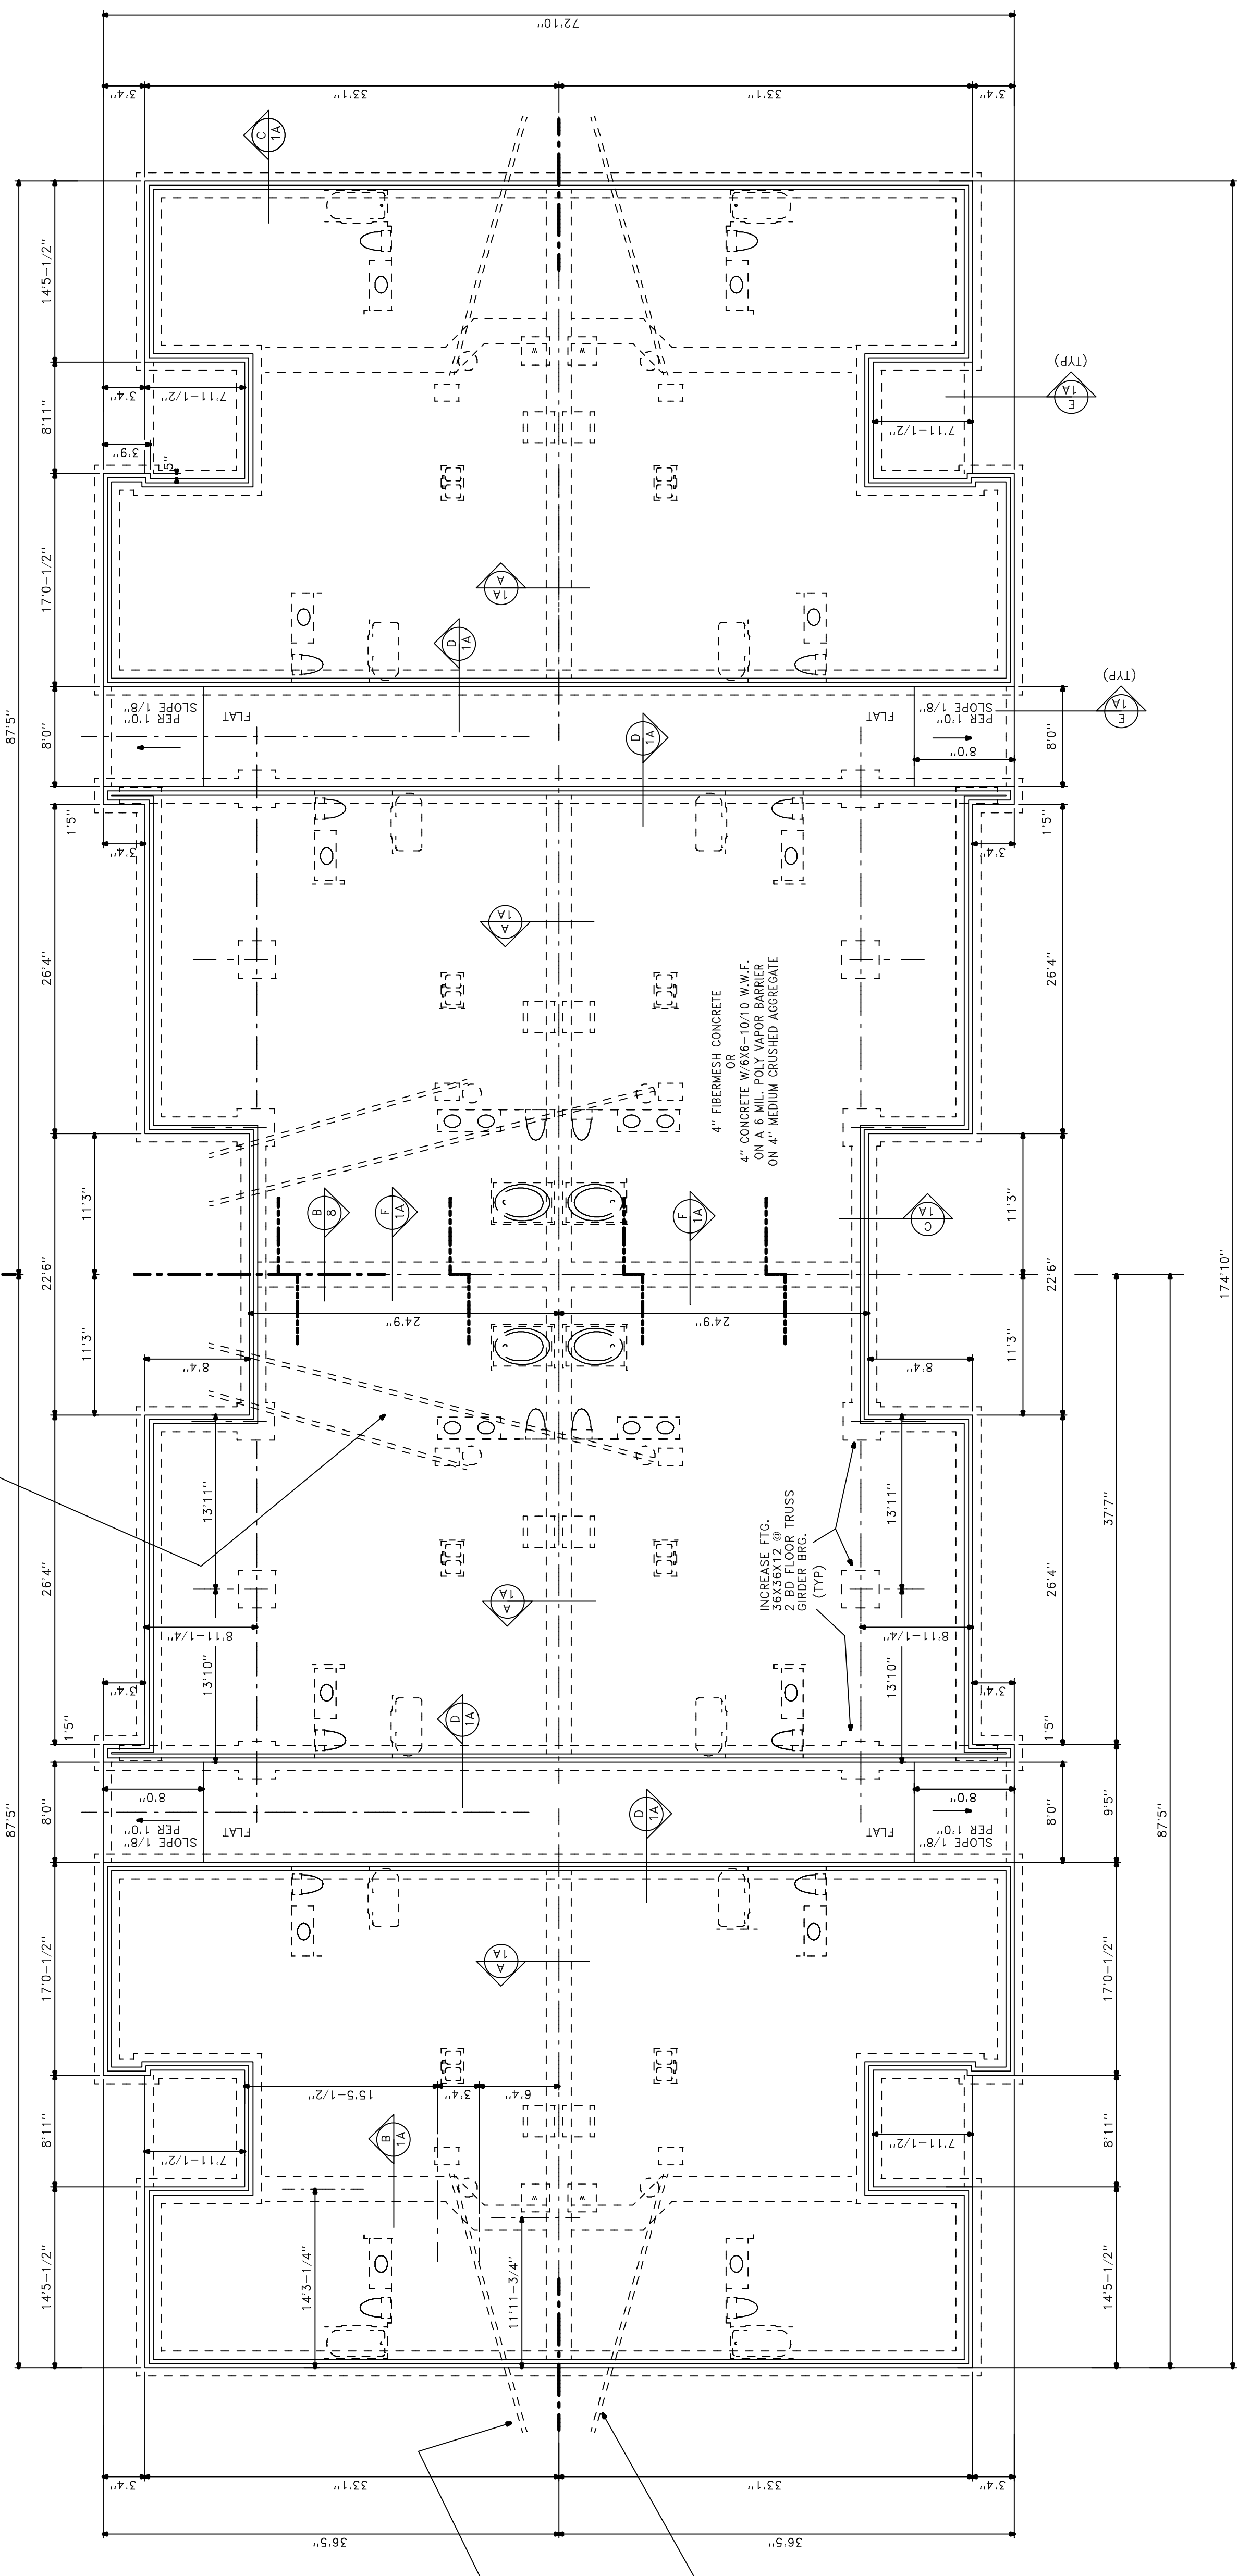

BLDG. CENTERLINE
SYMMETRICAL ABOUT
CENTERLINE

BLDG. SYMMETRICAL
ABOUT CENTER