


1 BEDROOM UNIT PLAN / 24 UNIT BLDG. TYPE 'A'

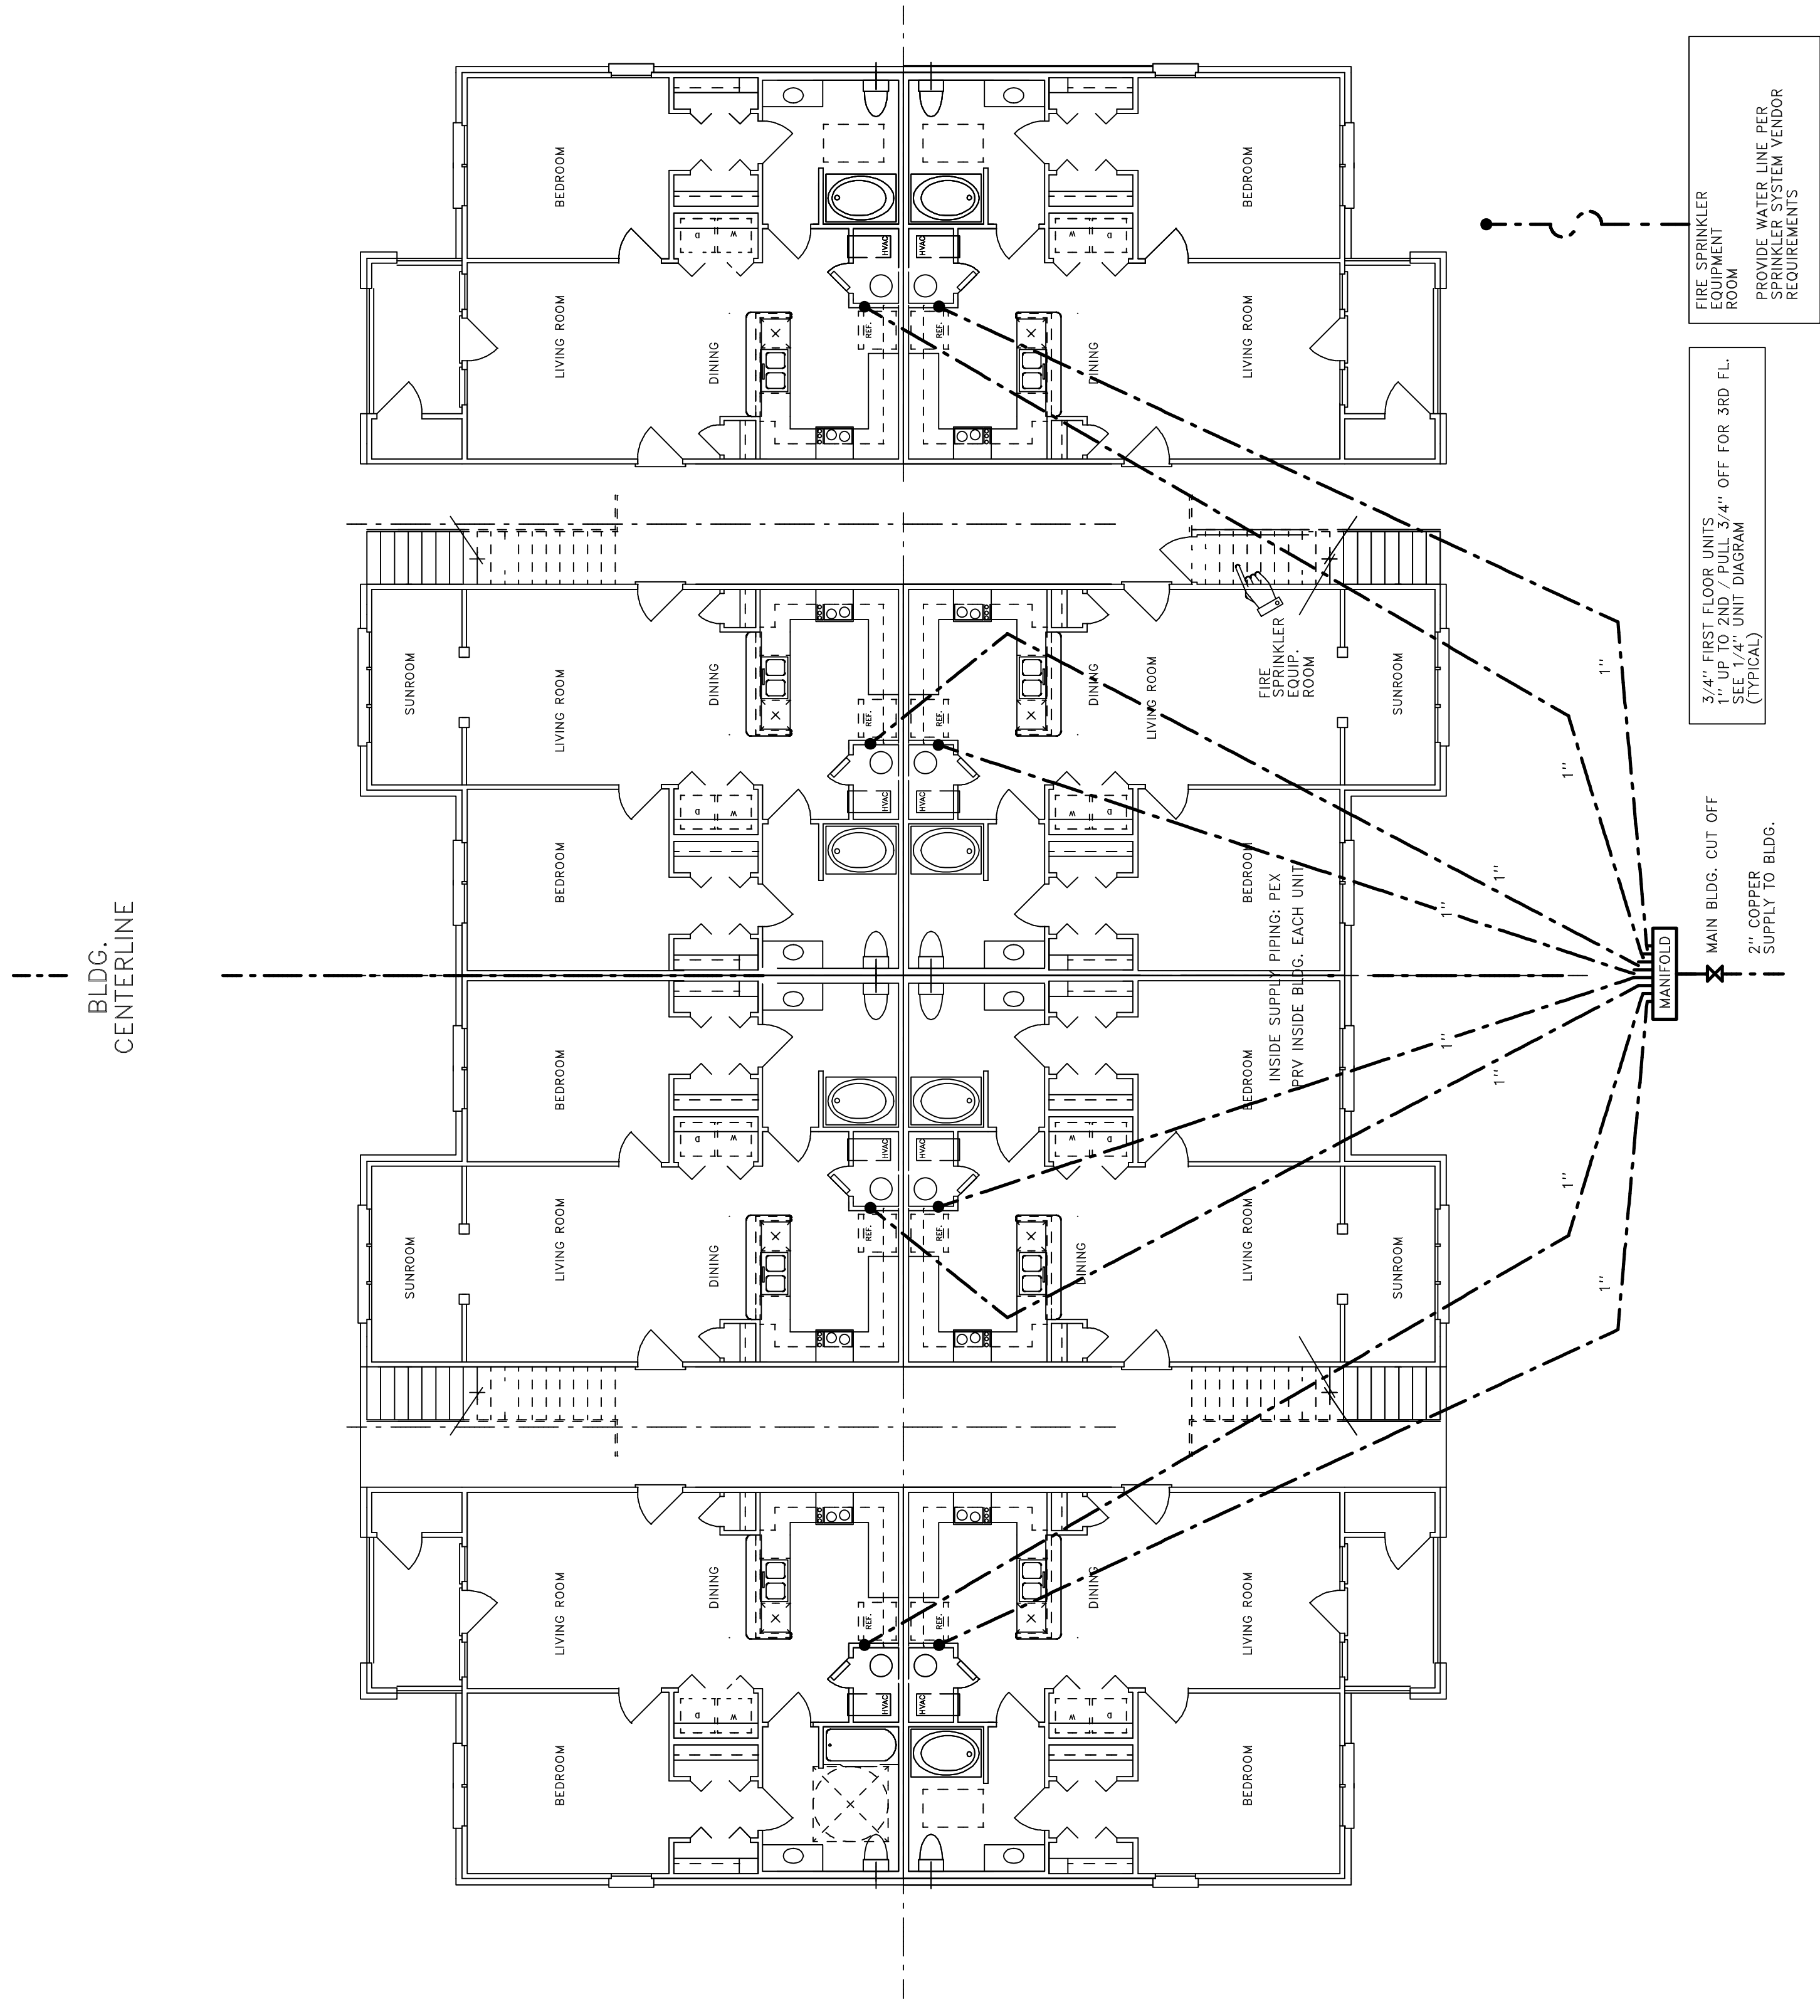

PLUMBING PLAN / BUILDING PLAN WATER SUPPLY

Scale: 1/8" = 1'0"

NOTE:
 REFERENCE THE FOLLOWING SECTIONS:
 2006 NC BUILDING CODE, ABC
 SECTION 712 PENETRATIONS- MAINTAINING FIRE RESISTANCE RATINGS