


JOB NO.	
DRAWN BY	CMH
CHECKED BY	CMH
DATE	4-22-2010
REVISIONS	
6-30-2010	
8-2-10	

SHEET NO.

P-2

2 BEDROOM UNIT PLAN / 24 UNIT BLDG. TYPE 'B'

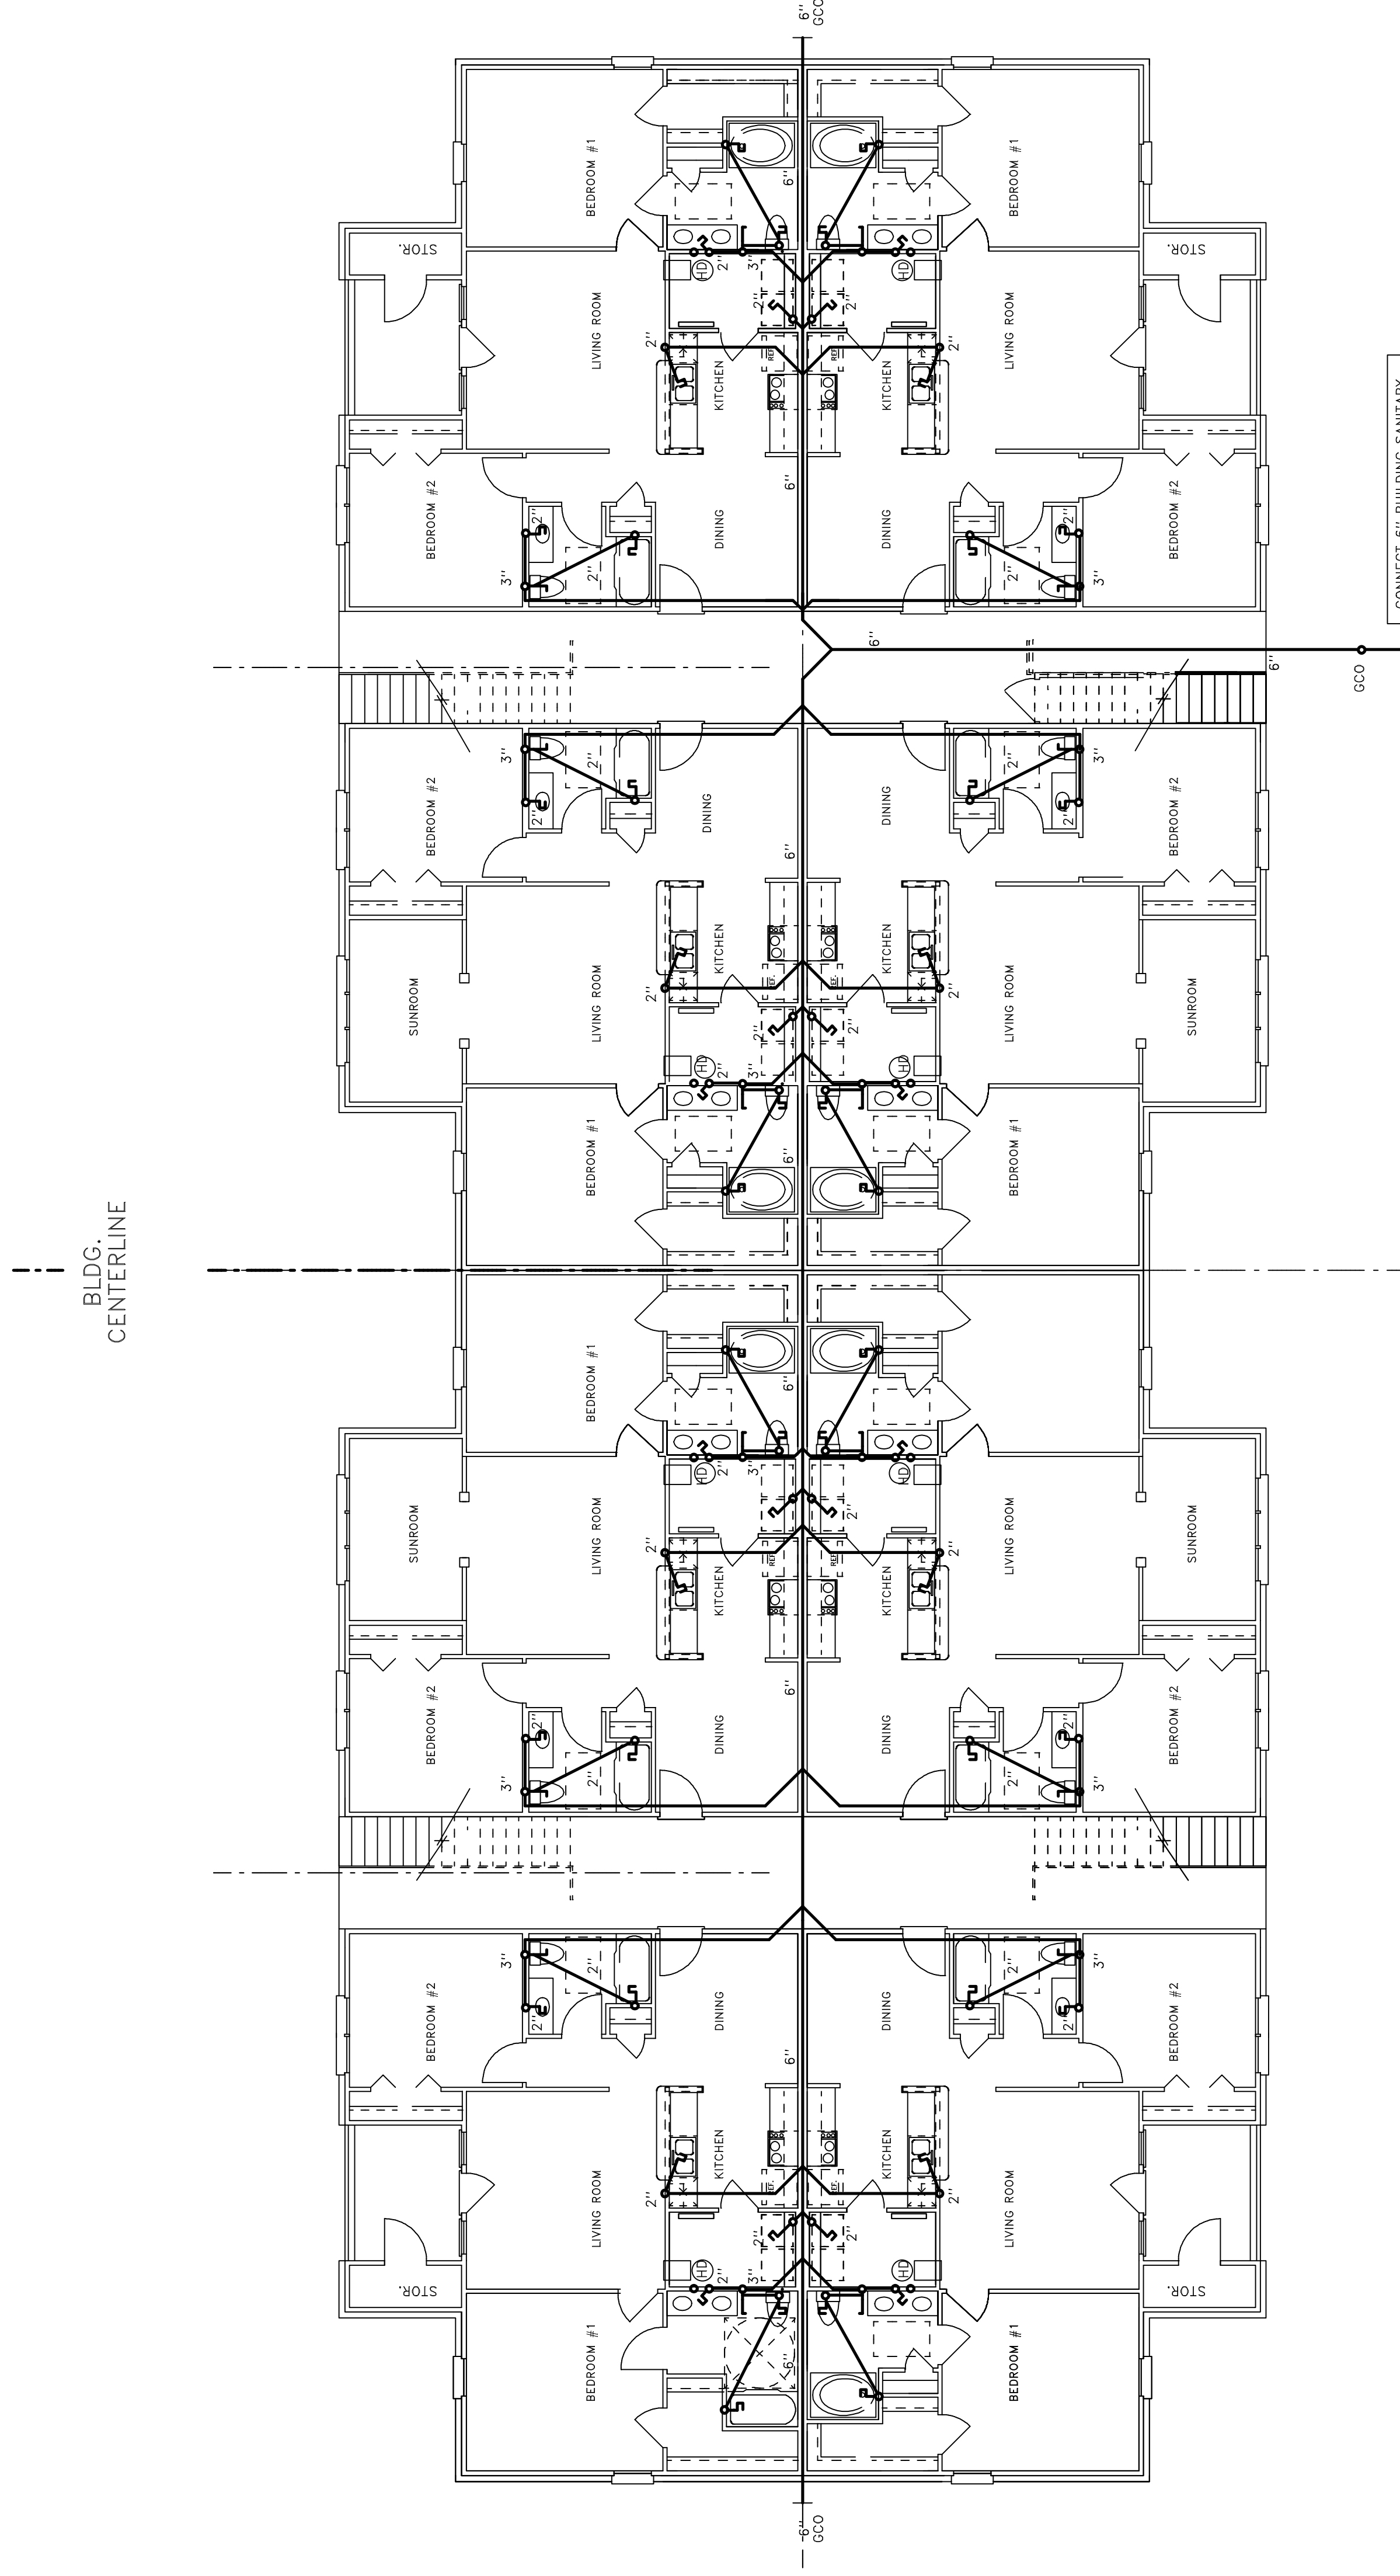

CONNECT 6" BUILDING SANITARY SEWERS TO SITE SEWER LATERAL FIELD VERIFY EXACT LOCATION AND INSTALLATION PRIOR TO INSTALLATION

NOTE: CONNECT 6" BUILDING SANITARY SEWERS TO SITE SEWER LATERAL FIELD VERIFY EXACT LOCATION AND INSTALLATION PRIOR TO INSTALLATION

NOTE: PROVIDE 3/4" COPPER OR CPVC DRAIN FOR W.H. (TYP. ALL UNITS)
PROVIDE 3/4" PVC CONDENSATION DRAIN ALL AHU (TYP. ALL UNITS)
(UL DESIGN) FC2007

NOTE: PROVIDE 3/4" COPPER OR CPVC DRAIN FOR W.H. (TYP. ALL UNITS)
PROVIDE 3/4" PVC CONDENSATION DRAIN ALL AHU (TYP. ALL UNITS)
(UL DESIGN) FC2007

NOTE: REFERENCE THE FOLLOWING SECTIONS:
NC BUILDING CODE / IBC
CHAPTER 7 PENETRATIONS: MAINTAINING FIRE RESISTANCE RATINGS

THE INTENT OF THESE DRAWINGS IS TO INDICATE IN GENERAL A DESCRIPTION OF THE PLUMBING SYSTEMS TO BE INSTALLED. THE CONTRACTOR SHALL BE RESPONSIBLE FOR OBTAINING ALL NECESSARY PERMITS AND EQUIPMENT SHALL PROVIDE A FUNCTIONAL AND OPERABLE PLUMBING SYSTEM.
NOTE:
PLUMBING PLAN AND RISER DIAGRAMS ARE SCHEMATIC.
ACTUAL INSTALLATION SCHEMES MAY VARY PER SUBCONTRACTOR TECHNIQUE.
THE CONTRACTOR SHALL VERIFY THE PLUMBING PLAN TO ACTUAL CONSTRUCTION CONDITIONS.

2 BEDROOM UNIT BLDG. / WASTE SCHEMATIC

SCALE: 1/8" = 1'0"