

| | |
|------------|-----------|
| JOB NO. | |
| DRAWN BY | CMH |
| CHECKED BY | CMH |
| DATE | 4-22-2010 |
| REVISIONS | |
| 6-30-2010 | |
| 8-2-2-10 | |

SHEET NO.
P-2.3




MOUNTAIN ISLAND LAKE APARTMENTS
MT. HOLLY/HUNTERSVILLE RD AND HWY 16
CHARLOTTE, NC 28216

OWNER / DEVELOPER:
MOUNTAIN ISLAND APARTMENTS, LLC
1329 EAST MOREHEAD STREET, SUITE 200
CHARLOTTE, NC 28204

CHARLES M. HILL, A.I.A.
ARCHITECT
NEBO, NC
TELEPHONE (828) 659-1540

2 BEDROOM UNIT PLAN / 24 UNIT BLDG. TYPE 'B'.

NOTE:
REFERENCE THE FOLLOWING SECTIONS:
2006 NC BUILDING CODE / IBC
SECTION 712 PENETRATIONS: MAINTAINING FIRE RESISTANCE RATINGS

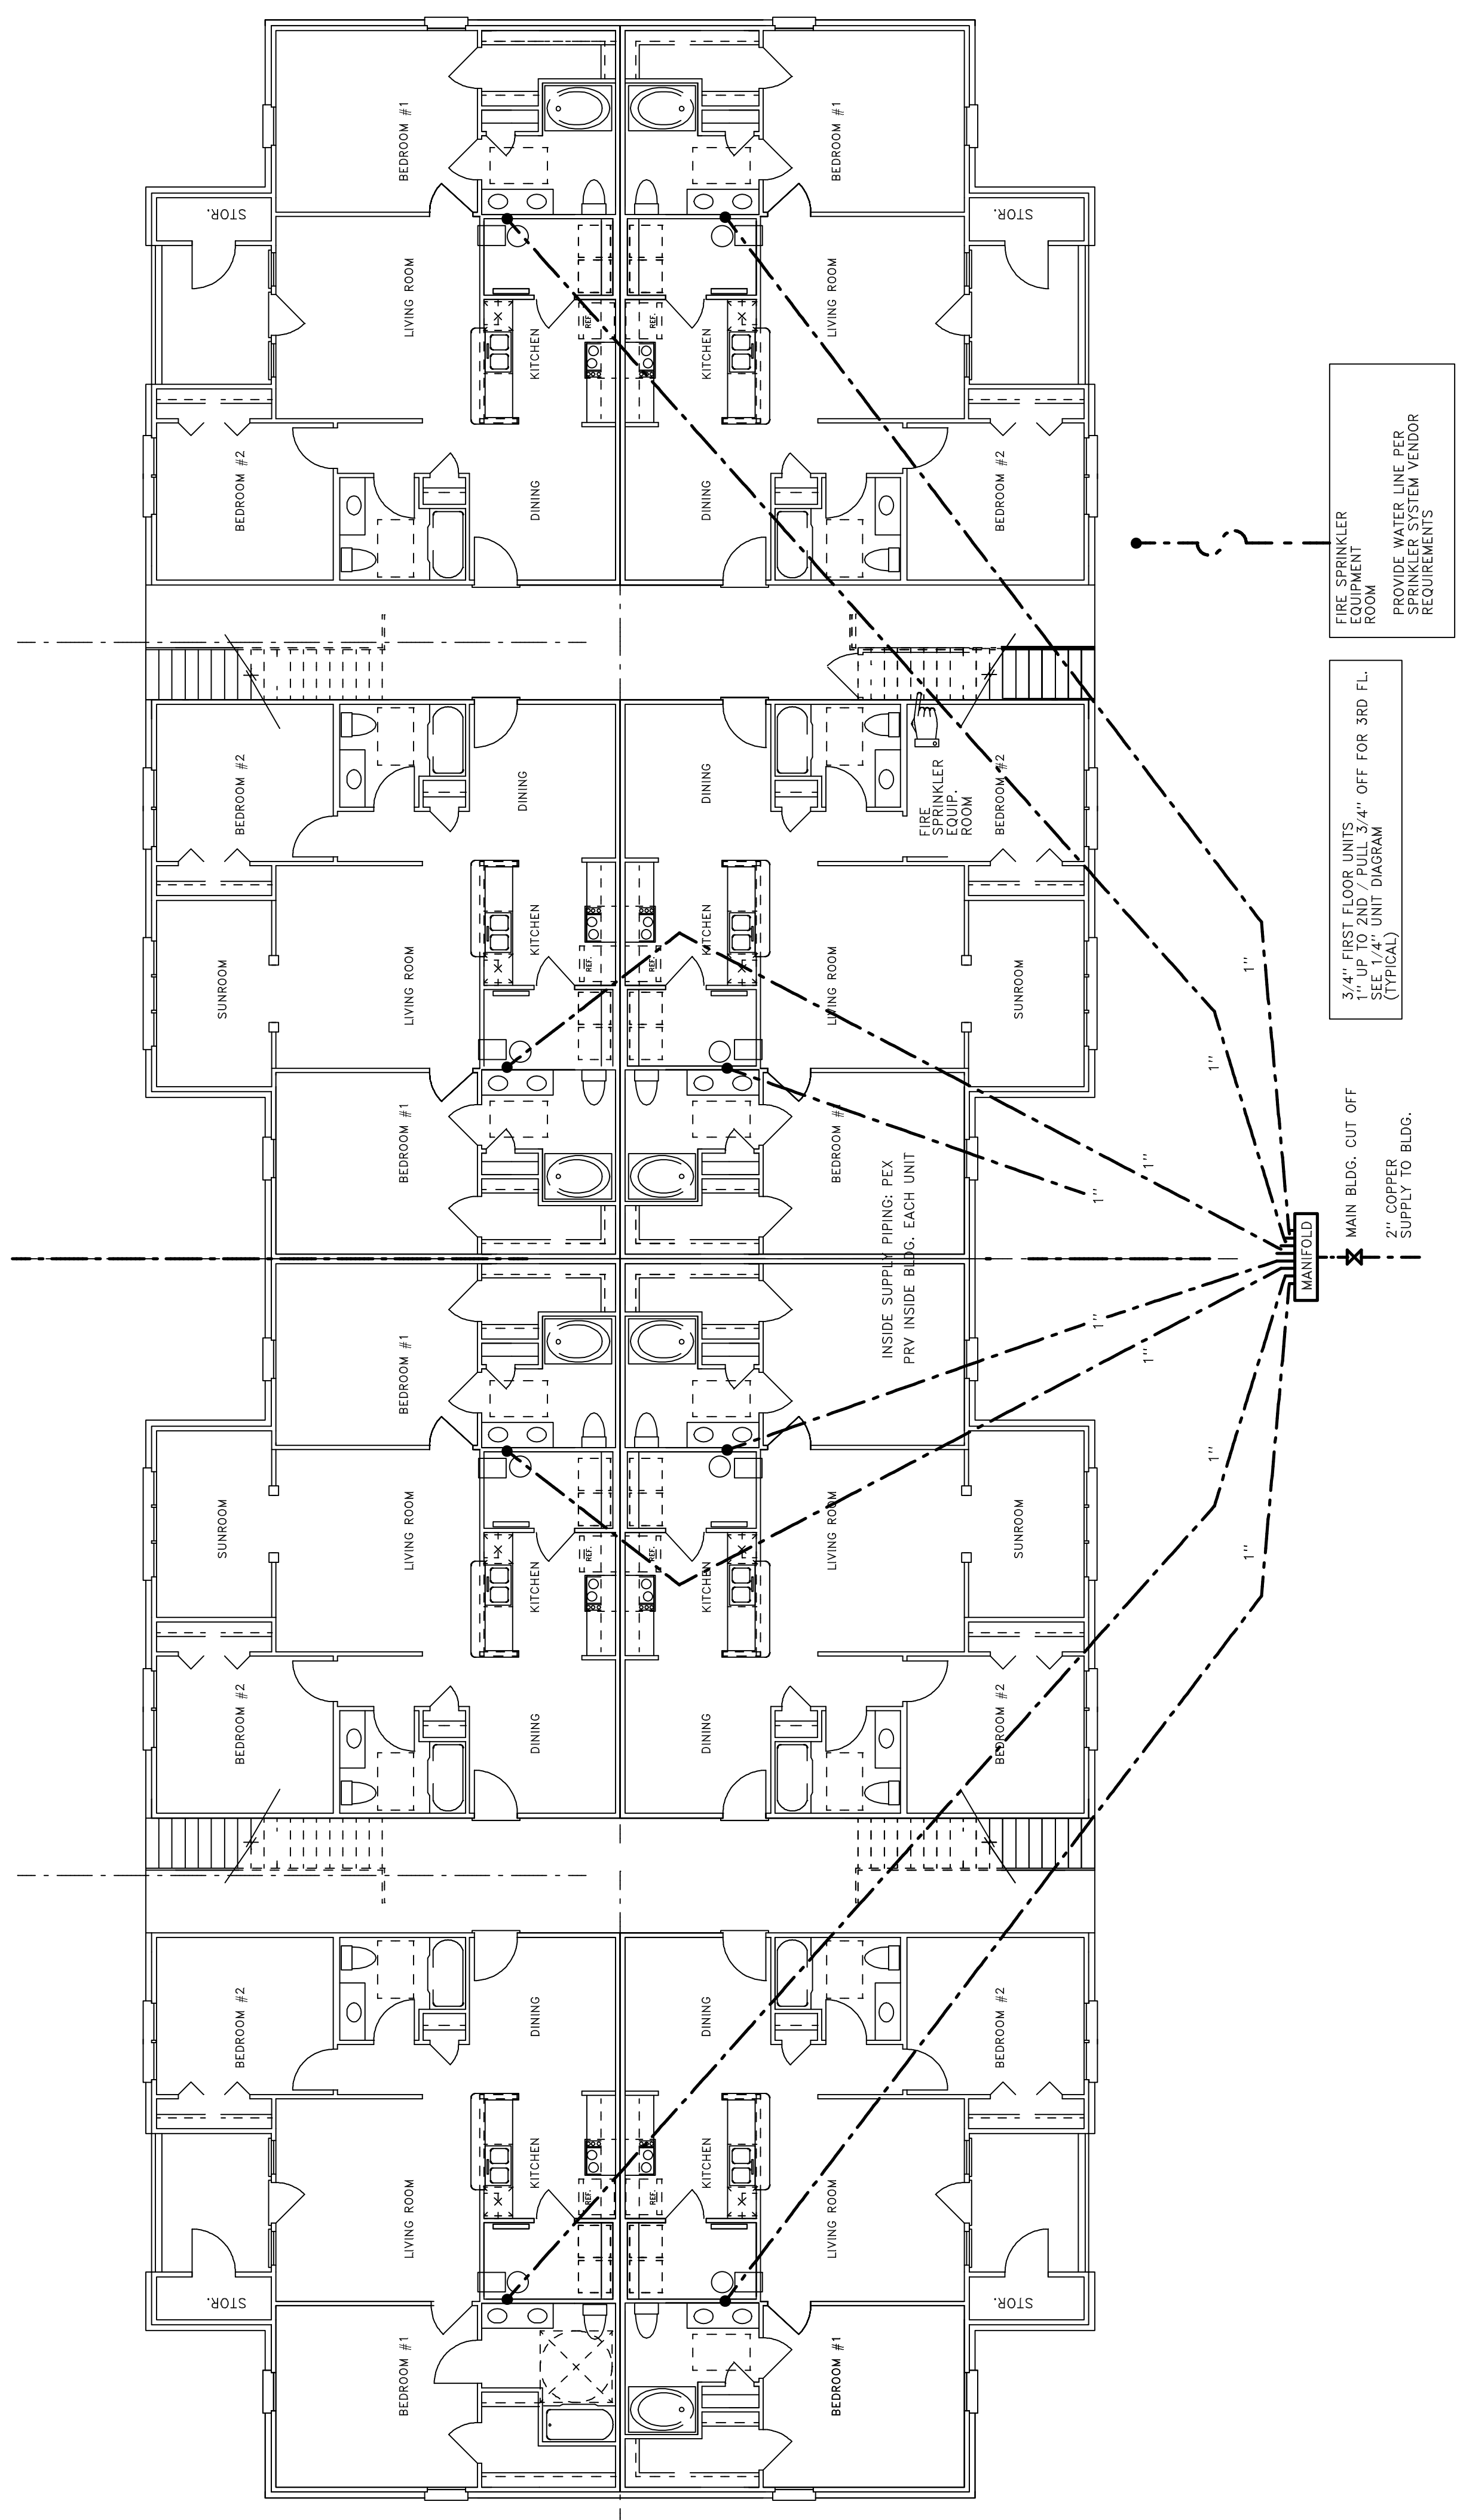

PLUMBING PLAN / BUILDING PLAN WATER SUPPLY

Scale: 1/8" = 1'0"

BLDG. CENTERLINE