


JOB NO.	
DRAWN BY	CMH
CHECKED BY	CMH
DATE	4-22-2010
REVISIONS	
6-30-2010	
8-2-10	

2 AND 3 BEDROOM UNIT BLDG. PLAN / 24 UNIT BLDG. TYPE 'C'

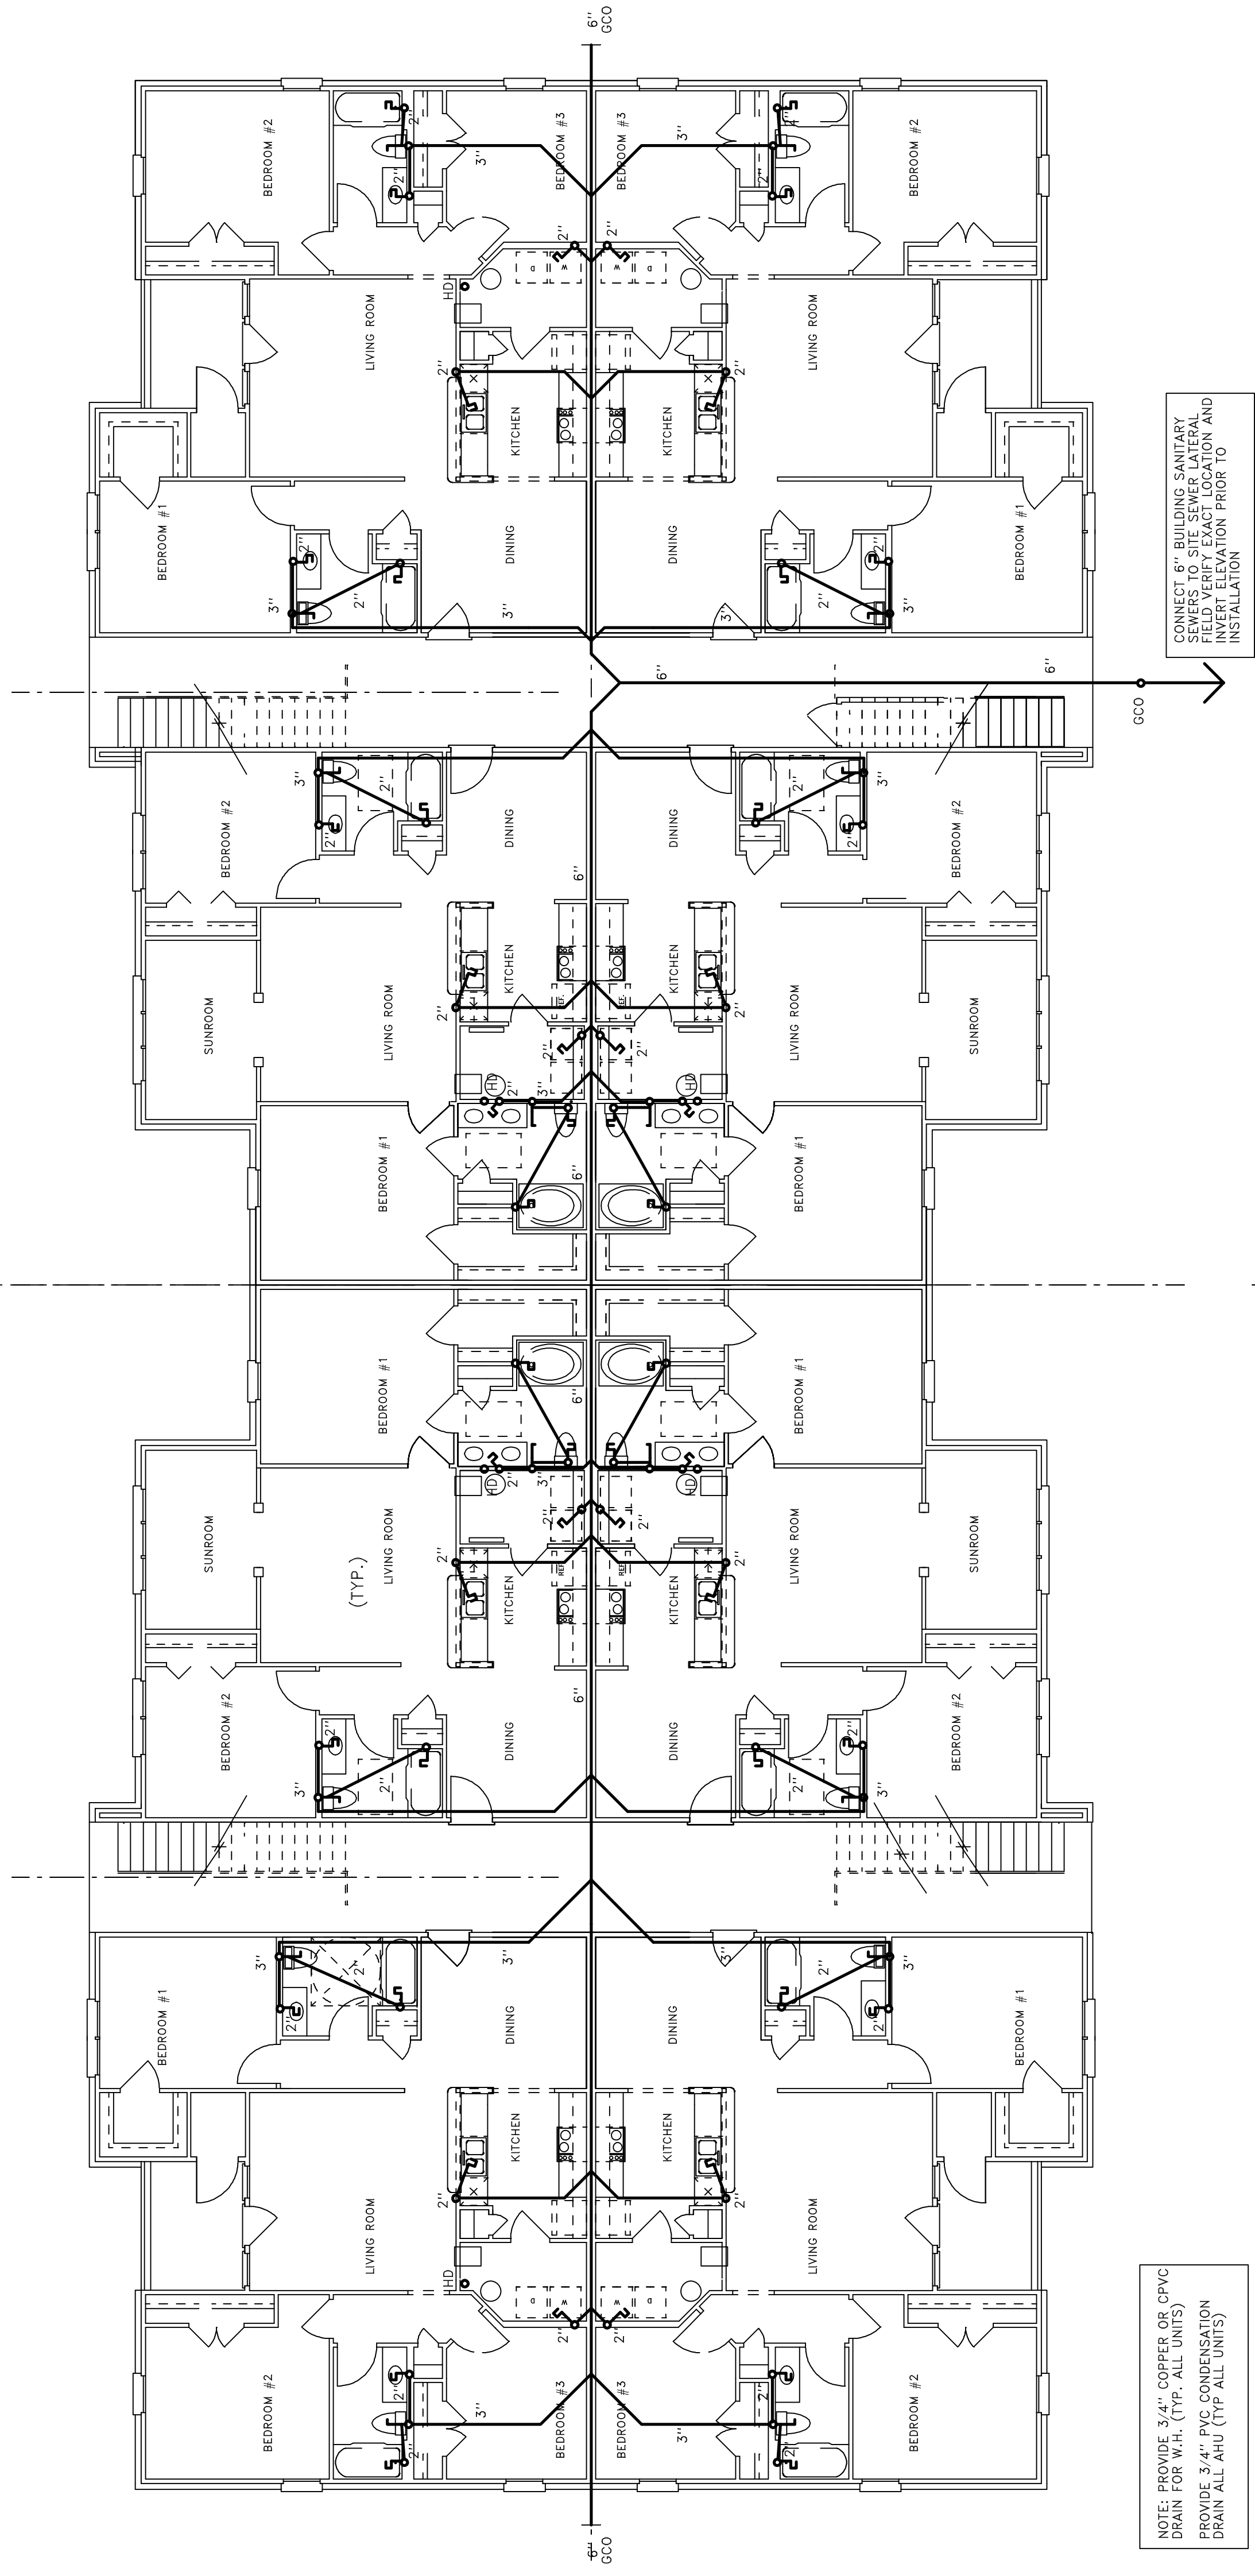

SCALE: 1/8" = 1'0"

2 AND 3 BEDROOM UNIT BLDG./ WASTE SCHEMATIC

NOTE:
CONNECT 6" BUILDING SANITARY SEWERS TO SITE SEWER LATERAL FIELD VERIFY EXACT LOCATION AND INVERT ELEVATION PRIOR TO INSTALLATION

NOTE:
ADDITIONAL GROUND CLEAN OUT (S) MAY BE REQUIRED FOR SANITARY WORK

NOTE:
PROVIDE 3/4" COPPER OR CPVC DRAIN FOR W.H. (TYP. ALL UNITS)
PROVIDE 3/4" PVC CONDENSATION DRAIN ALL AHU (TYP. ALL UNITS)

NOTE:
ALL FLOOR PENETRATIONS (P&E TRADES) SHALL BE INSTALLED IN ACCORDANCE WITH ALL APPLICABLE NATIONAL, STATE AND LOCAL CODES. PROVIDE 3" FIRE DAM, 150 CALK OR EQUAL TOP & BOT. PLATE (UL DESIGN) FC2007

NOTE:
REFERENCE THE FOLLOWING SECTIONS:
SECTION 15000 - PLUMBING
SECTION 15000 - PLUMBING
CHAPTER 7 PENETRATIONS: MAINTAINING FIRE RESISTANCE RATINGS

NOTE:
THE INTENT OF THESE DRAWINGS IS TO INDICATE IN GENERAL A DESCRIPTION OF THE PLUMBING SYSTEM FOR THE STRUCTURE. ALL WORK MUST BE INSTALLED IN ACCORDANCE WITH ALL APPLICABLE NATIONAL, STATE AND LOCAL CODES. ALL NECESSARY CONNECTIONS AND EQUIPMENT SHALL PROVIDE A FUNCTIONAL AND OPERABLE PLUMBING SYSTEM.
NOTE:
PLUMBING PLAN AND RISER DIAGRAMS ARE SCHEMATIC. SUBCONTRACTOR TECHNIQUE AND ACTUAL INSTALLATION SCHEMES MAY VARY PER WHEN ADAPTING PLAN TO ACTUAL CONSTRUCTION CONDITIONS.